


PROPOSED DRAINAGE PLAN

NTS

CDM RESIDUAL HAZARD INFORMATION

(IN ADDITION TO THE HAZARDS / RISKS NORMALLY ASSOCIATED WITH THE TYPES OF WORK DETAILED ON THIS DRAWING, NOTE THE FOLLOWING)

1. DEEP EXCAVATION
THE INSTALLATION OF NEW MANHOLES REQUIRES DEEP EXCAVATION. THE EXISTING GROUND CONDITIONS ARE UNKNOWN. MAN ENTRY TO THE EXCAVATIONS SHOULD NOT BE PERMITTED WITHOUT ADEQUATE TEMPORARY SUPPORT OF THE SIDES TO PREVENT COLLAPSE.

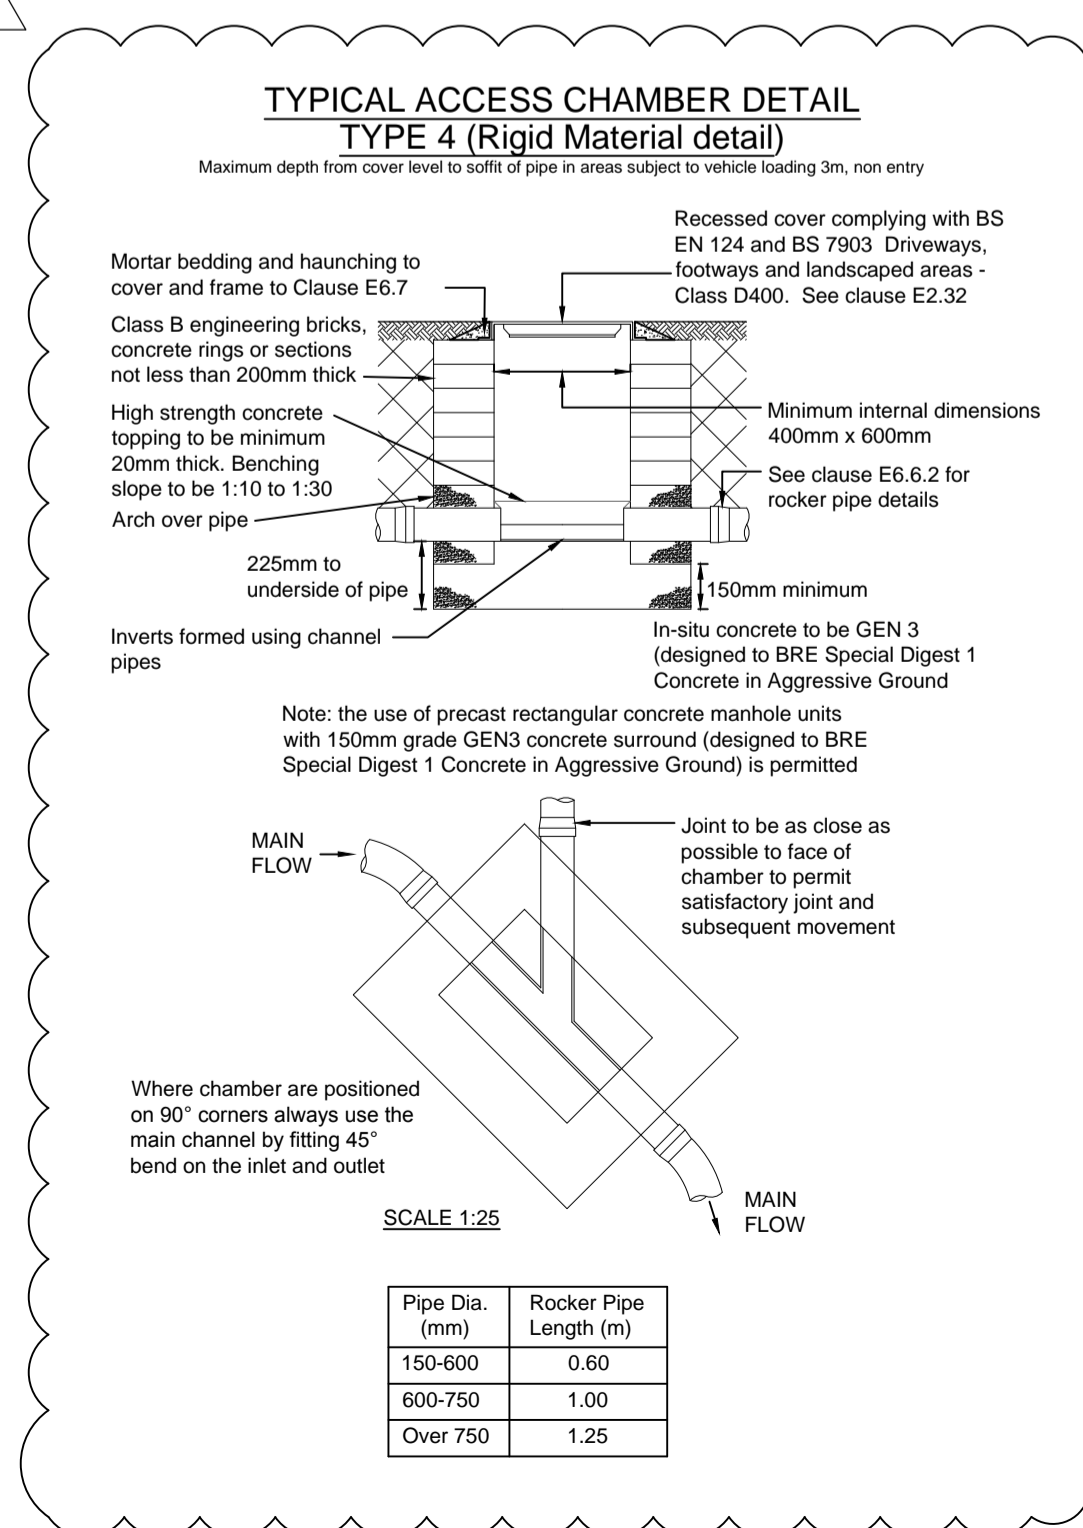

- KEYPLAN
- NOTES
- ALL DIMENSIONS ARE TO BE CHECKED ON SITE BEFORE THE COMMENCEMENT OF WORKS. ANY DISCREPANCIES ARE TO BE REPORTED TO THE ARCHITECT & ENGINEER FOR VERIFICATION. FIGURED DIMENSIONS ONLY ARE TO BE TAKEN FROM THIS DRAWING.
 - THIS DRAWING IS TO BE READ IN CONJUNCTION WITH ALL RELEVANT ENGINEERS' AND SERVICE ENGINEERS' DRAWINGS AND SPECIFICATIONS. THIS DRAWING IS COPYRIGHT.
 - ALL WORK TO COMPLY WITH THE RELEVANT BRITISH STANDARDS, CODES OF PRACTICE AND BUILDING REGULATIONS.
 - NEW MANHOLE COVERS TO BE RECESSED TYPE TO SUIT PAVING. MIN CLASS B125.

ABANDONED

REVISIONS

NO.	DATE	BY	DESCRIPTION
P02	25/04/19	J.COATES	NOTES UPDATED/ADDED. DRAINAGE LAYOUT UPDATED. MANHOLE DETAIL ADDED
P01	04/04/19	J.COATES	FIRST ISSUE
REV	04/04/19	J.COATES	REVISION NOTES/COMMENTS

Hydrock

Lobb Shippon
Plympton
Plymouth
PL7 5BP

t: +44 (0) 1752 347515
e: plymouth@hydrock.com

CLIENT
TAVISTOCK GUILDHALL

PROJECT
TAVISTOCK GUILDHALL

TITLE
PROPOSED DRAINAGE PLAN

HYDROCK PROJECT NO. C-03482	SCALE @ A1 N.T.S.
STATUS DESCRIPTION SUITABLE FOR TENDER	STATUS D2
DRAWING NO. (PROJECT CODE-ORIGINATOR ZONE-LEVEL-TYPE-ROLE-NUMBER) TGH-HYD-XX-ZZ-DR-S-0101	REVISION P02