



Ground Floor Plan  
scale 1-50

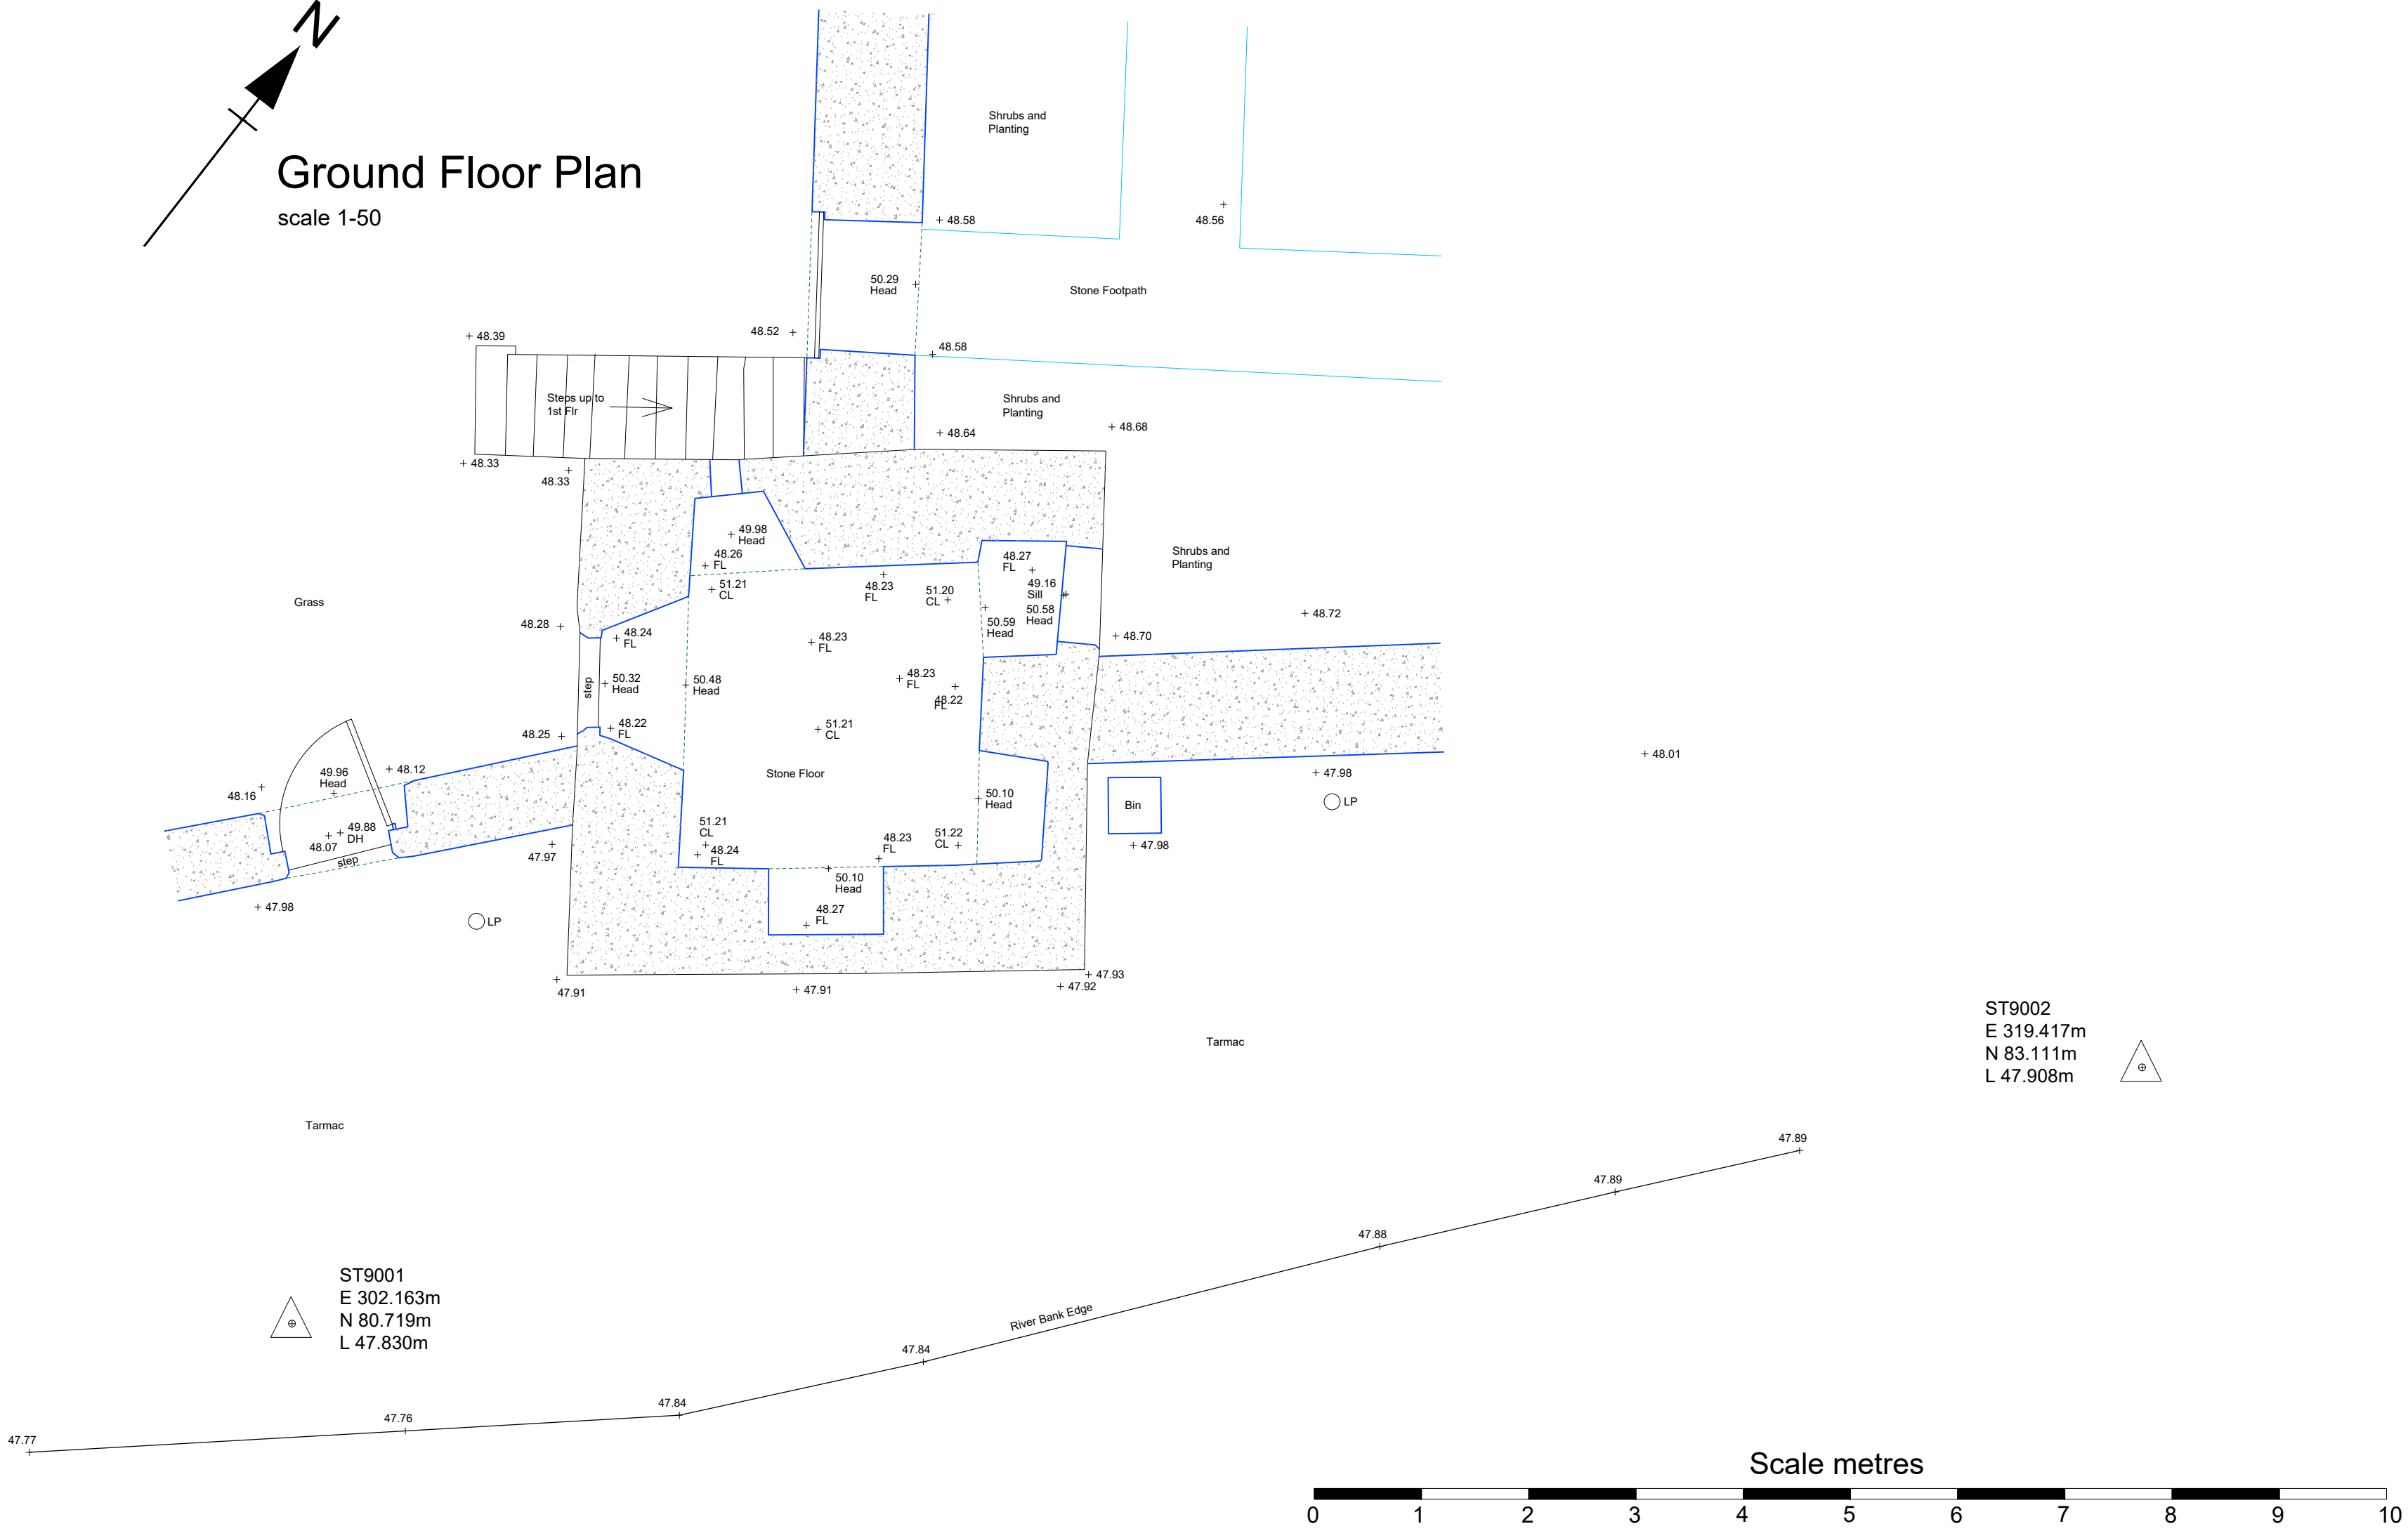

1st Floor Plan  
scale 1-50

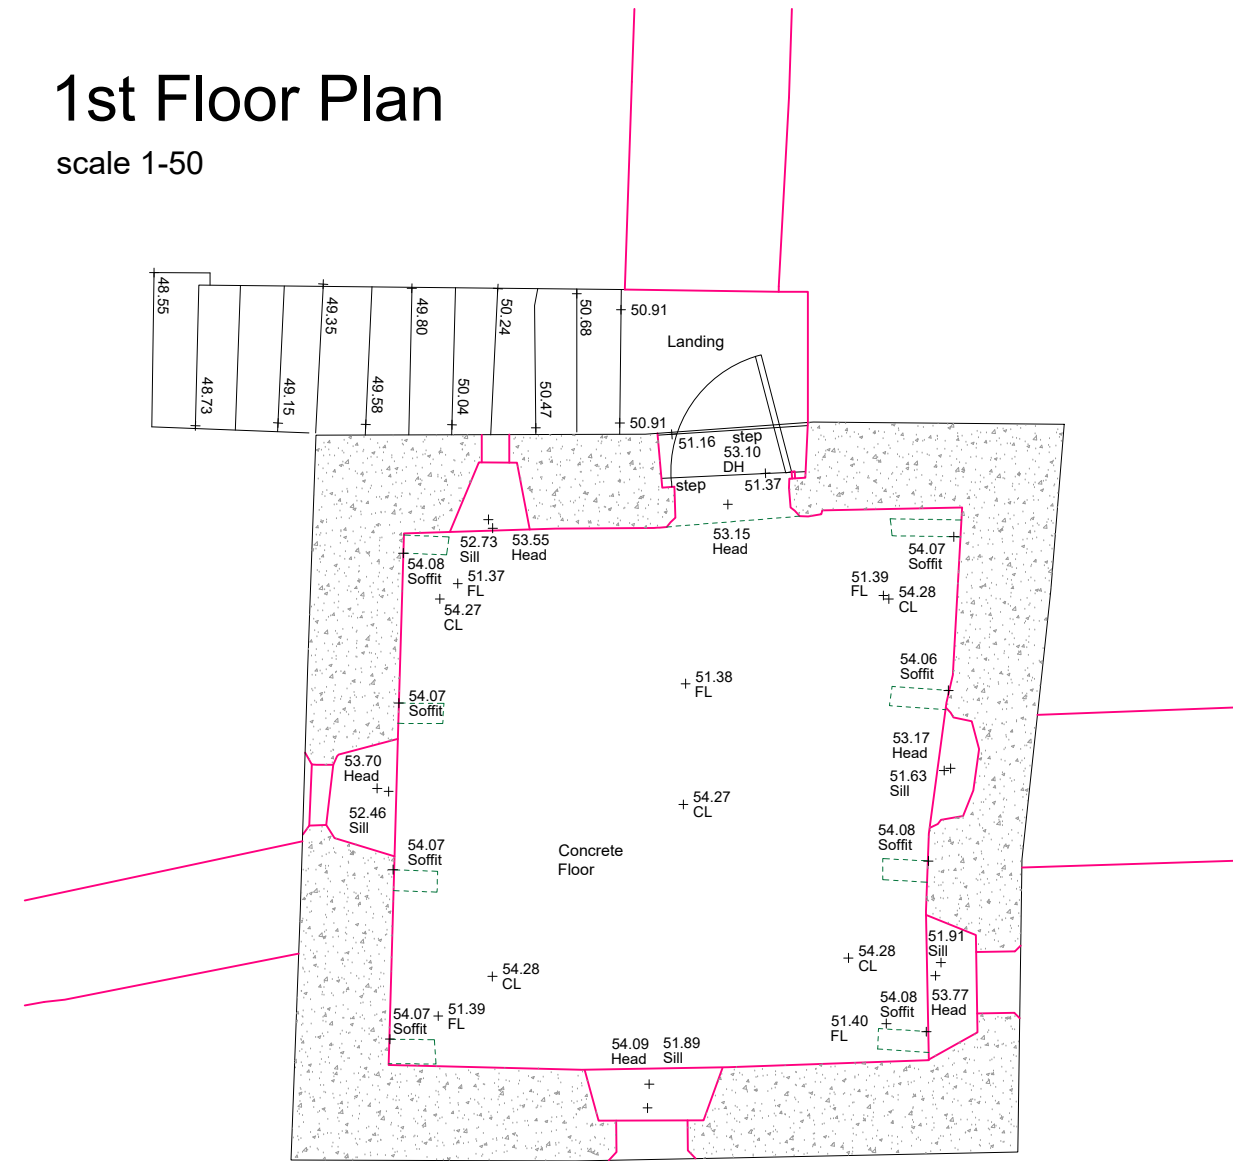

- Notes
1. Survey set to arbitrary grid and level datum. Grid orientated to magnetic North.
  2. Dimensions and elevations in metres.
  3. Boundary features shown on this plan may not delineate legal boundaries.
  4. While every effort has been made to survey all areas of the site, no responsibility can be accepted for errors and omissions caused by detail being obscured or not accessible at the time of the survey.

KEY

- CV Cover Level
- CL Ceiling Level
- CWT Cold Water Tank
- EP Electric Pole
- EM Electricity Meter
- FH Fire Hydrant
- FL Floor Level
- FC Floor Ceiling Distance
- FP Fireplace
- G Gully
- Gas Gas cover
- HWI Hot Water Tank
- IV Invert Level
- L Light Fitting
- LP Lighting Pole
- MH Manhole
- PO Timber Post
- R Radiator
- RE Roofing Eye
- RWP Rainwater Pipe
- SP Sign Pole
- SV Soil Vent Pipe
- SVP Soave valve cover
- ToB Top of Bank
- ToF Top of Fence
- ToH Top of Hedge
- ToT Top of Tree
- ToW Top of Wall
- TP Telegraph Pole
- V Vent
- VWP Vent Water Pipe
- WL Water Level
- WM / SC Water meter / stop cock
- Hedge / Vegetation
- Tree Canopy
- Building Eaves
- Open sided building
- Top / Bottom embankment
- Post & rail fence (timber)
- Chickenwire fence
- Chainlink fence
- Picket fence
- Post & wire fence
- Security fence
- Timber panel fence
- Overhead Electricity
- Overhead Telephone
- Survey Station / Benchmark
- Tree Deciduous or Evergreen & Trunk diameter
- Tree Fir / Pine & Trunk diameter
- Shrub / bush
- Embankment
- Stone / Cob Wall
- Concrete Slab
- Stud or Lath Wall

01 First Issue JP 20-01-17

Issue Description Drawn Chkd Date

Client

Le Page Architects

Project

Still House Tower  
Tavistock

Title

Measured Survey

PRESTON ENGINEERING SURVEY

Site Engineering Land Surveying Measured Building Surveys  
Trelodya House Lewannick Launceston  
Cornwall PL15 7QD  
Tel: 01566 782 149  
Mob: 07791 889 823  
email: prestonengsurvey@yahoo.co.uk  
web: www.prestonengsurvey.co.uk

Scale (A1) Date Datum

As Shown 20-01-17 Local

Job Code Drawing No. Issue

0920 0001 1st